
 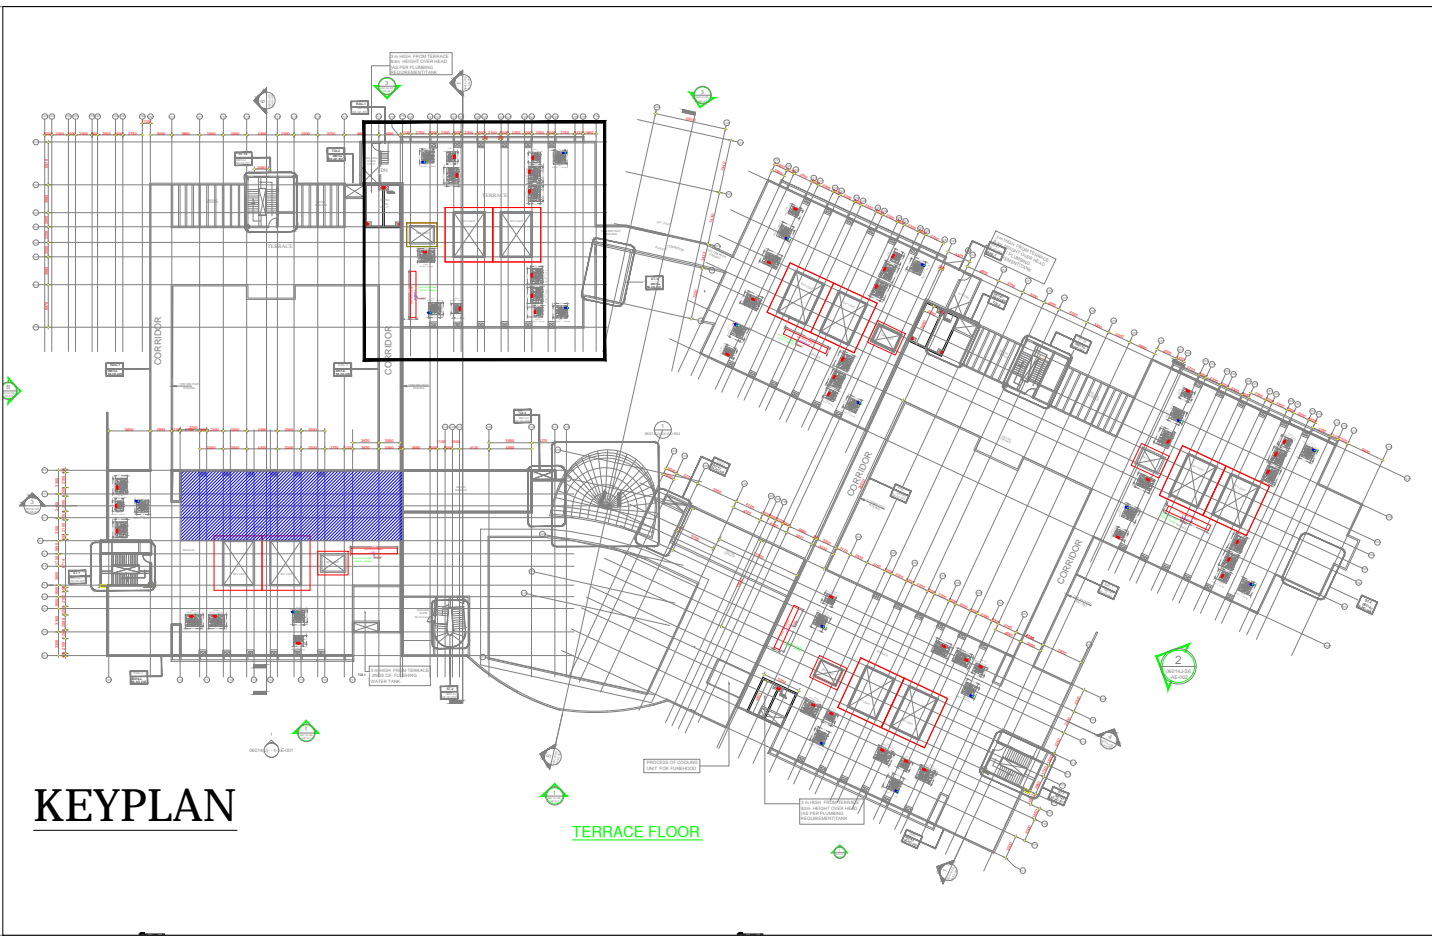




3300 3750 4800 3000 1130 2750 1000 2300 1000 2300 1000 2100 1000 2300 1000 2300 1000 2750 1130 1850

100 100

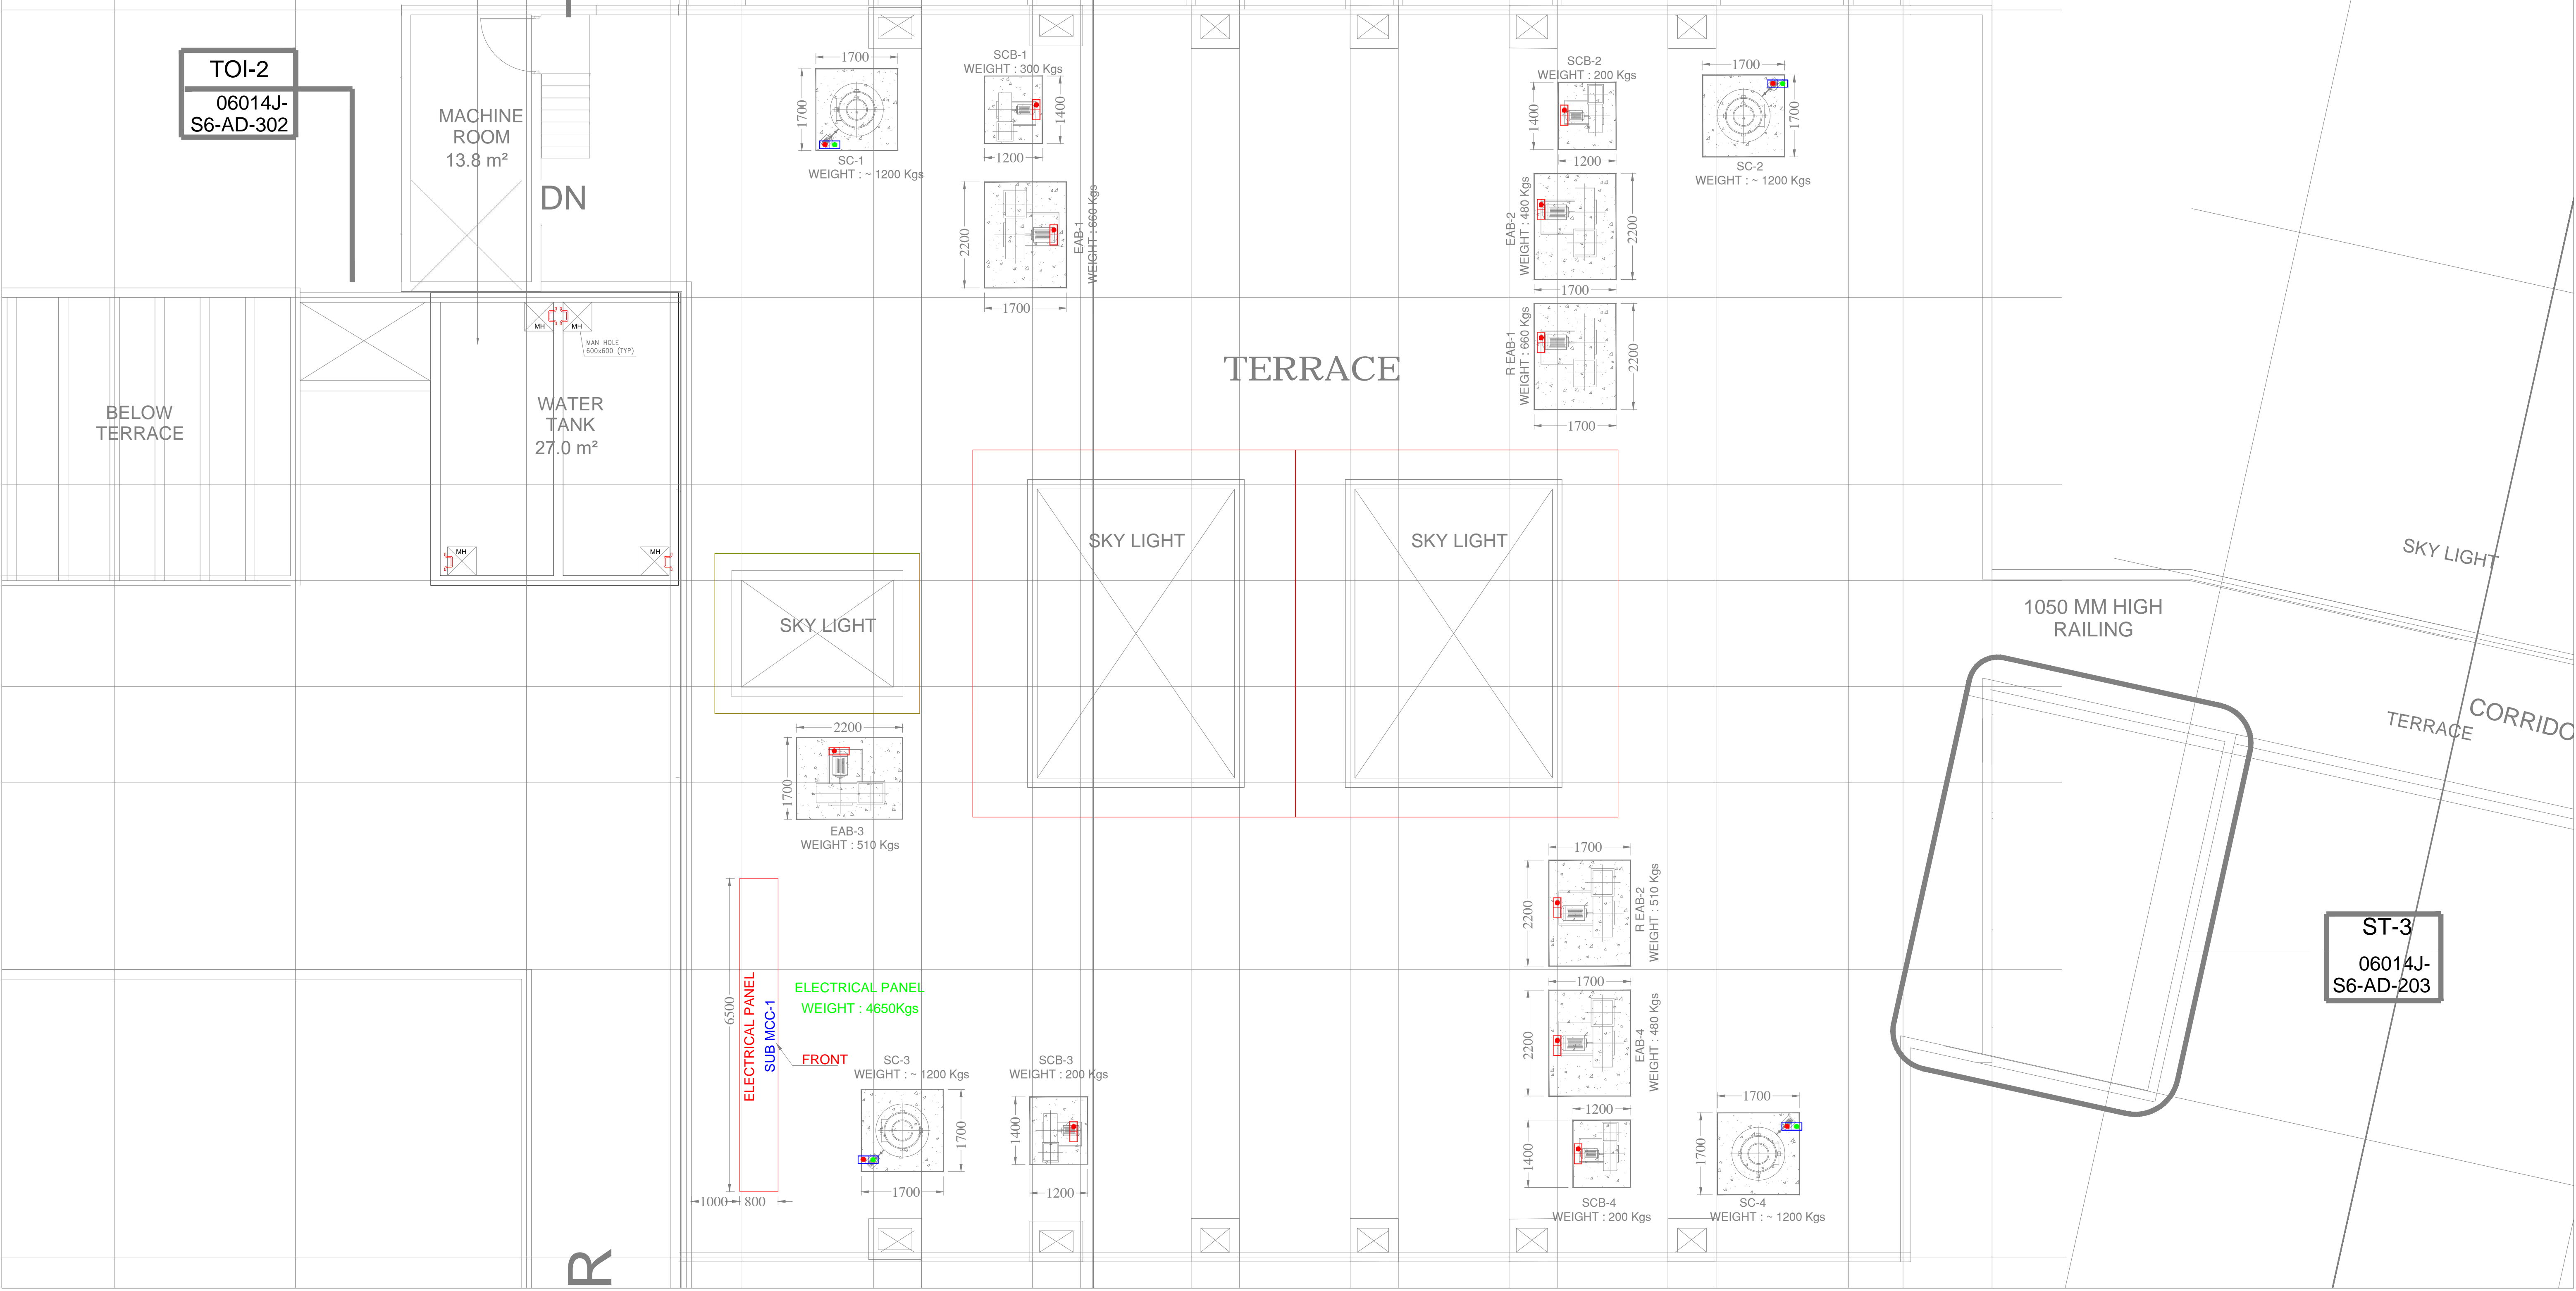

LEGEND:			
SL. NO	SYMBOL	DESCRIPTION	QTY
01		WEATHER PROOF EMERGENCY STOP MUSH ROOM TYPE PUSH BUTTON STATION WITH KEY LOCKABLE	10
02		WEATHER PROOF ON & OFF PUSH BUTTON STATION WITH FRONT PLATE & KEY LOCKABLE TYPE	04

CLIENT:	 Indian Institute of Science Bangalore	INDIAN INSTITUTE OF SCIENCE, BANGALORE.	Architect:	Chandroo Iyer Associates	DRAWN	CHETAN
				NO 69, 15TH "A" CROSS ,6th MAIN	CHECKED	SANDEEPA
				MALLESWARAM	APPROVED	MJA
				BANGALORE 560 055.	DATE	23.03.2019
				TEL - 80- 23368319	JOB NO	MJ - 324
PROJECT:	LABORATORY INTERIOR WORKS FOR CHEMICAL SCIENCES BUILDING.		Consultant:	M J ASSOCIATES	DWG NO:	ELE- 2445 (a)
				PROJECT ENGINEERING CONSULTANTS	SCALE	NTS
				#45,1st Floor,8th Main road,	REVISION	TR 0
				Vasanth nagar,Bangalore-560 052		
				Tele:-22284583,22204636		
				E-mail:-projects@mjassociates.in/www.mjassociates.in		
			DRAWING TITLE:	POWER LAYOUT FOR 'A' TOP TERRACE FLOOR		
			DRAWING STATUS : TENDER DRAWINGS			