











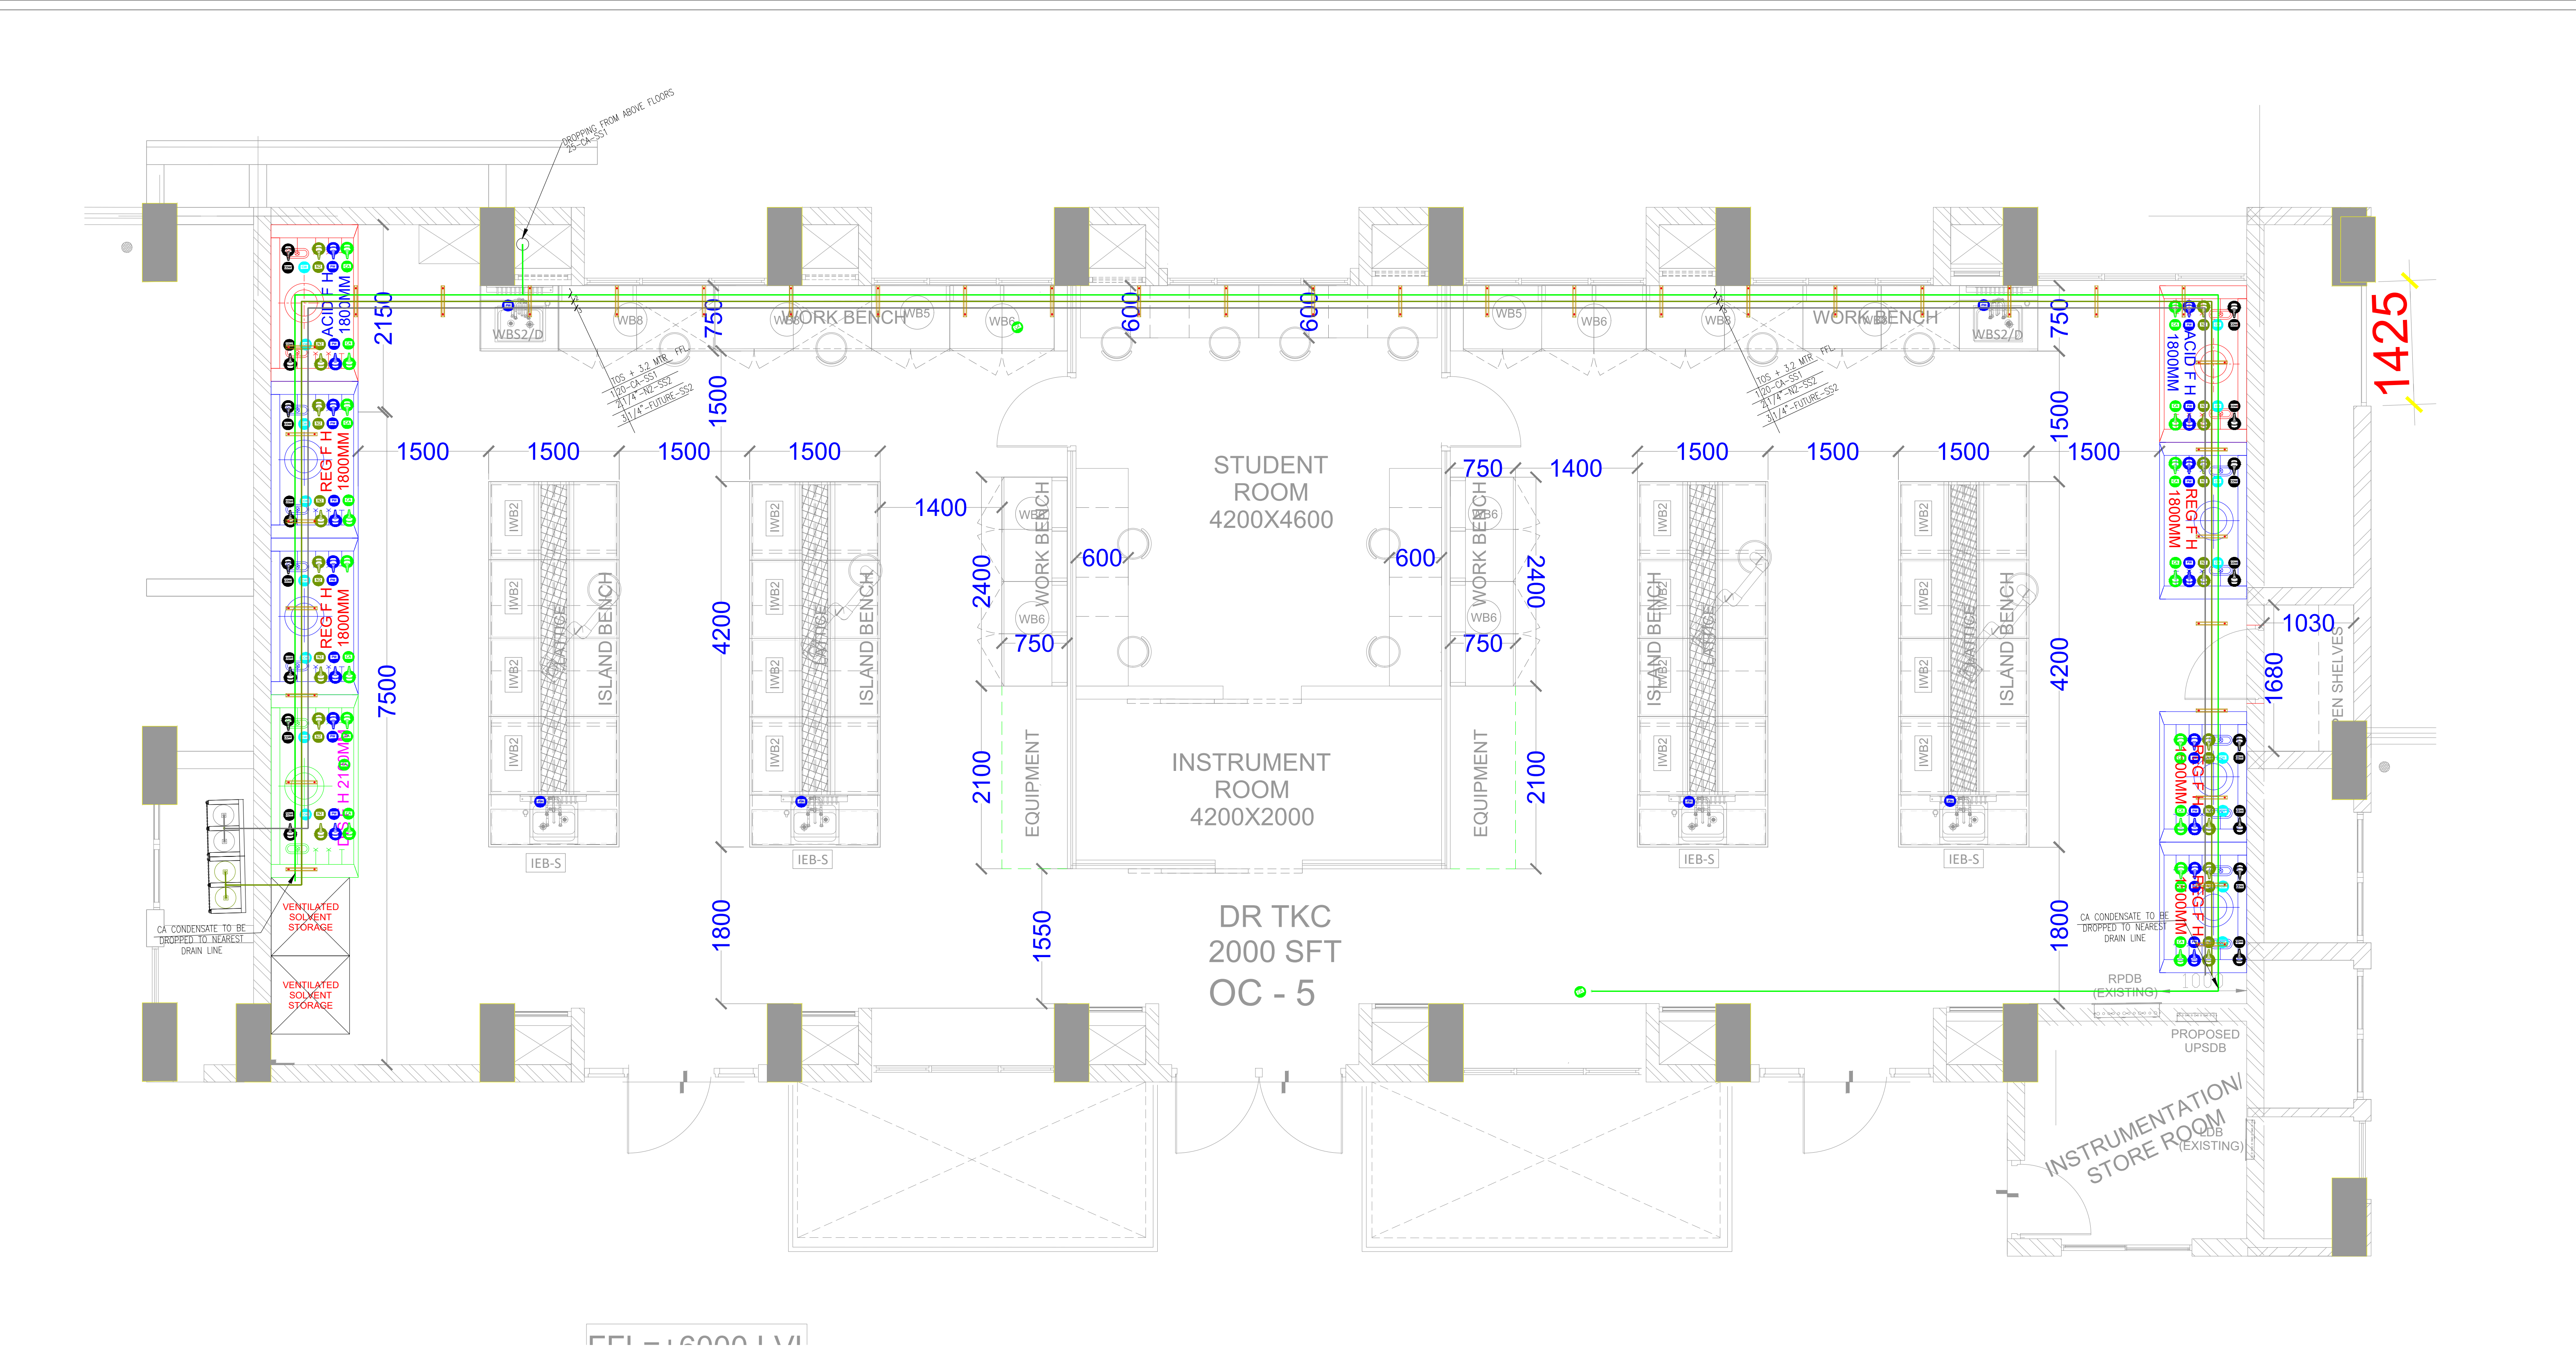


<div>LEGEND:</div> <div><div> HELIUM GAS</div><div> ARGON GAS</div><div> HYDROGEN</div><div> COOLING WATER</div><div> OXYGEN</div><div> ACETYLENE</div><div> COMPRESSED AIR</div><div> CARBON DI OXIDE</div><div> NITROGEN</div><div> METHANE</div><div> FUTURE GAS</div><div> TOS TOP OF STEEL</div><div> FFL FINISHED FLOOR LEVEL</div></div>	<div>CLIENT:</div> <div><div>INDIAN INSTITUTE OF SCIENCE, BANGALORE.</div></div>	<div>Architect:</div> <div><div>Chandroo Iyer Associates</div><div>NO 69, 15TH "A" CROSS, 6th MAIN MALLESWARAM BANGALORE 560 055 TEL - 80- 23368319</div></div>	<div>DRAWN</div> <div>ABHI</div>	
			<div>CHECKED</div> <div>BGK</div>	
			<div>APPROVED</div> <div>SUNDAR</div>	
			<div>DATE</div> <div>25.03.2019</div>	
			<div>JOB NO</div> <div>MJ - 324</div>	
			<div>DWG NO:</div> <div>PIPE-DR-4802(f)</div>	
			<div>SCALE</div> <div>NTS</div>	
			<div>REVISION</div> <div>TR 0</div>	
		<div>PROJECT:</div> <div>LABORATORY INTERIOR WORKS FOR CHEMICAL SCIENCES BUILDING.</div>	<div>DRAWING TITLE:</div> <div>GAS PIPING LAYOUT FOR OC - 6 @C TOP - FIRST FLOOR - WEST SIDE</div>	
			<div>DRAWING STATUS : TENDER DRAWINGS</div>	



<div>LEGEND:</div> <div><div><div>HELIUM GAS</div><div>ARGON GAS</div><div>HYDROGEN</div><div>COOLING WATER</div><div>OXYGEN</div><div>ACETYLENE</div><div>COMPRESSED AIR</div><div>CARBON DI OXIDE</div><div>NITROGEN</div><div>METHANE</div><div>FUTURE GAS</div><div>TOP OF STEEL</div><div>FINISHED FLOOR LEVEL</div></div></div>	<div>CLIENT:</div> <div><div><div><div><div></div><div>Indian Institute of Science Bangalore</div></div></div><div>INDIAN INSTITUTE OF SCIENCE, BANGALORE.</div></div></div> <div><div>PROJECT:</div><div>LABORATORY INTERIOR WORKS FOR CHEMICAL SCIENCES BUILDING.</div></div>	<div>Architect:</div> <div><div>Chandroo Iyer Associates</div><div><div>NO 69, 15TH "A" CROSS, 6th MAIN</div><div>MALLESWARAM</div><div>BANGALORE 560 055.</div><div>TEL - 80- 23368319</div></div></div>	<div>DRAWN</div> <div>ABHI</div>
		<div>CHECKED</div> <div>BGK</div>	
		<div>APPROVED</div> <div>SUNDAR</div>	
		<div>DATE</div> <div>25.03.2019</div>	
		<div>JOB NO</div> <div>MJ - 324</div>	
		<div>DWG NO:</div> <div>PIPE-DR-4802(e)</div>	
		<div>SCALE</div> <div>NTS</div>	
		<div>REVISION</div> <div>TR 0</div>	
		<div>DRAWING TITLE:</div> <div><div>GAS PIPING LAYOUT FOR OC - 5</div><div>@C TOP - FIRST FLOOR - EAST SIDE</div></div>	
		<div>DRAWING STATUS : TENDER DRAWINGS</div>	